

1 REMODEL NW SECOND FLOOR FIRE SPRINKLER PLAN - FAMILY PRACTICE SUITE


FP3-RM1 SCALE: 1/4" = 1'-0"

GENERAL NOTES

1. THE REMODEL CONTRACTOR AND ALL SUBCONTRACTORS SHALL VERIFY ALL DIMENSIONS AND CONDITIONS AT THE SITE AND NOTIFY THE OWNER AND BLUEFEATHER DESIGN/BUILD OF ANY DISCREPANCY.
2. ALL WORKMANSHIP AND BUILDING MATERIALS SHALL CONFORM TO THE CURRENT LOCAL AND INTERNATIONAL BUILDING CODES THAT APPLY.
3. ALL PLUMBING, MECHANICAL, AND ELECTRICAL WORK MUST BE DONE BY LICENSED CONTRACTORS.

PAGE NOTES

1. THIS PLAN HAS BEEN REDRAFT FROM ORIGINAL PERMIT SET WITH ASBUILT NOTES AND CHANGES FROM FP3
2. THE PURPOSE OF THIS REMODEL IS TO ACCOMMODATE AN ADDITIONAL MEDICAL DOCTOR TO THE FAMILY PRACTICE
3. FOR TYP. RESTROOM PLANS REFER TO ORIGINAL SHEET A5.7
4. ALL DIMENSIONS ARE FRAMING DIMENSIONS
5. USE 20 GA. 4" x 6" STEEL STUDS FOR ALL NEW WALL FRAMING
6. FOR TYP. FIRE SPRINKLER NOTES AND SPECIFICATIONS REFER TO ORIGINAL FP1, FP2, FP3
7. NOTE NOT ALL EXISTING SPRINKLER INFORMATION IS PROVIDED

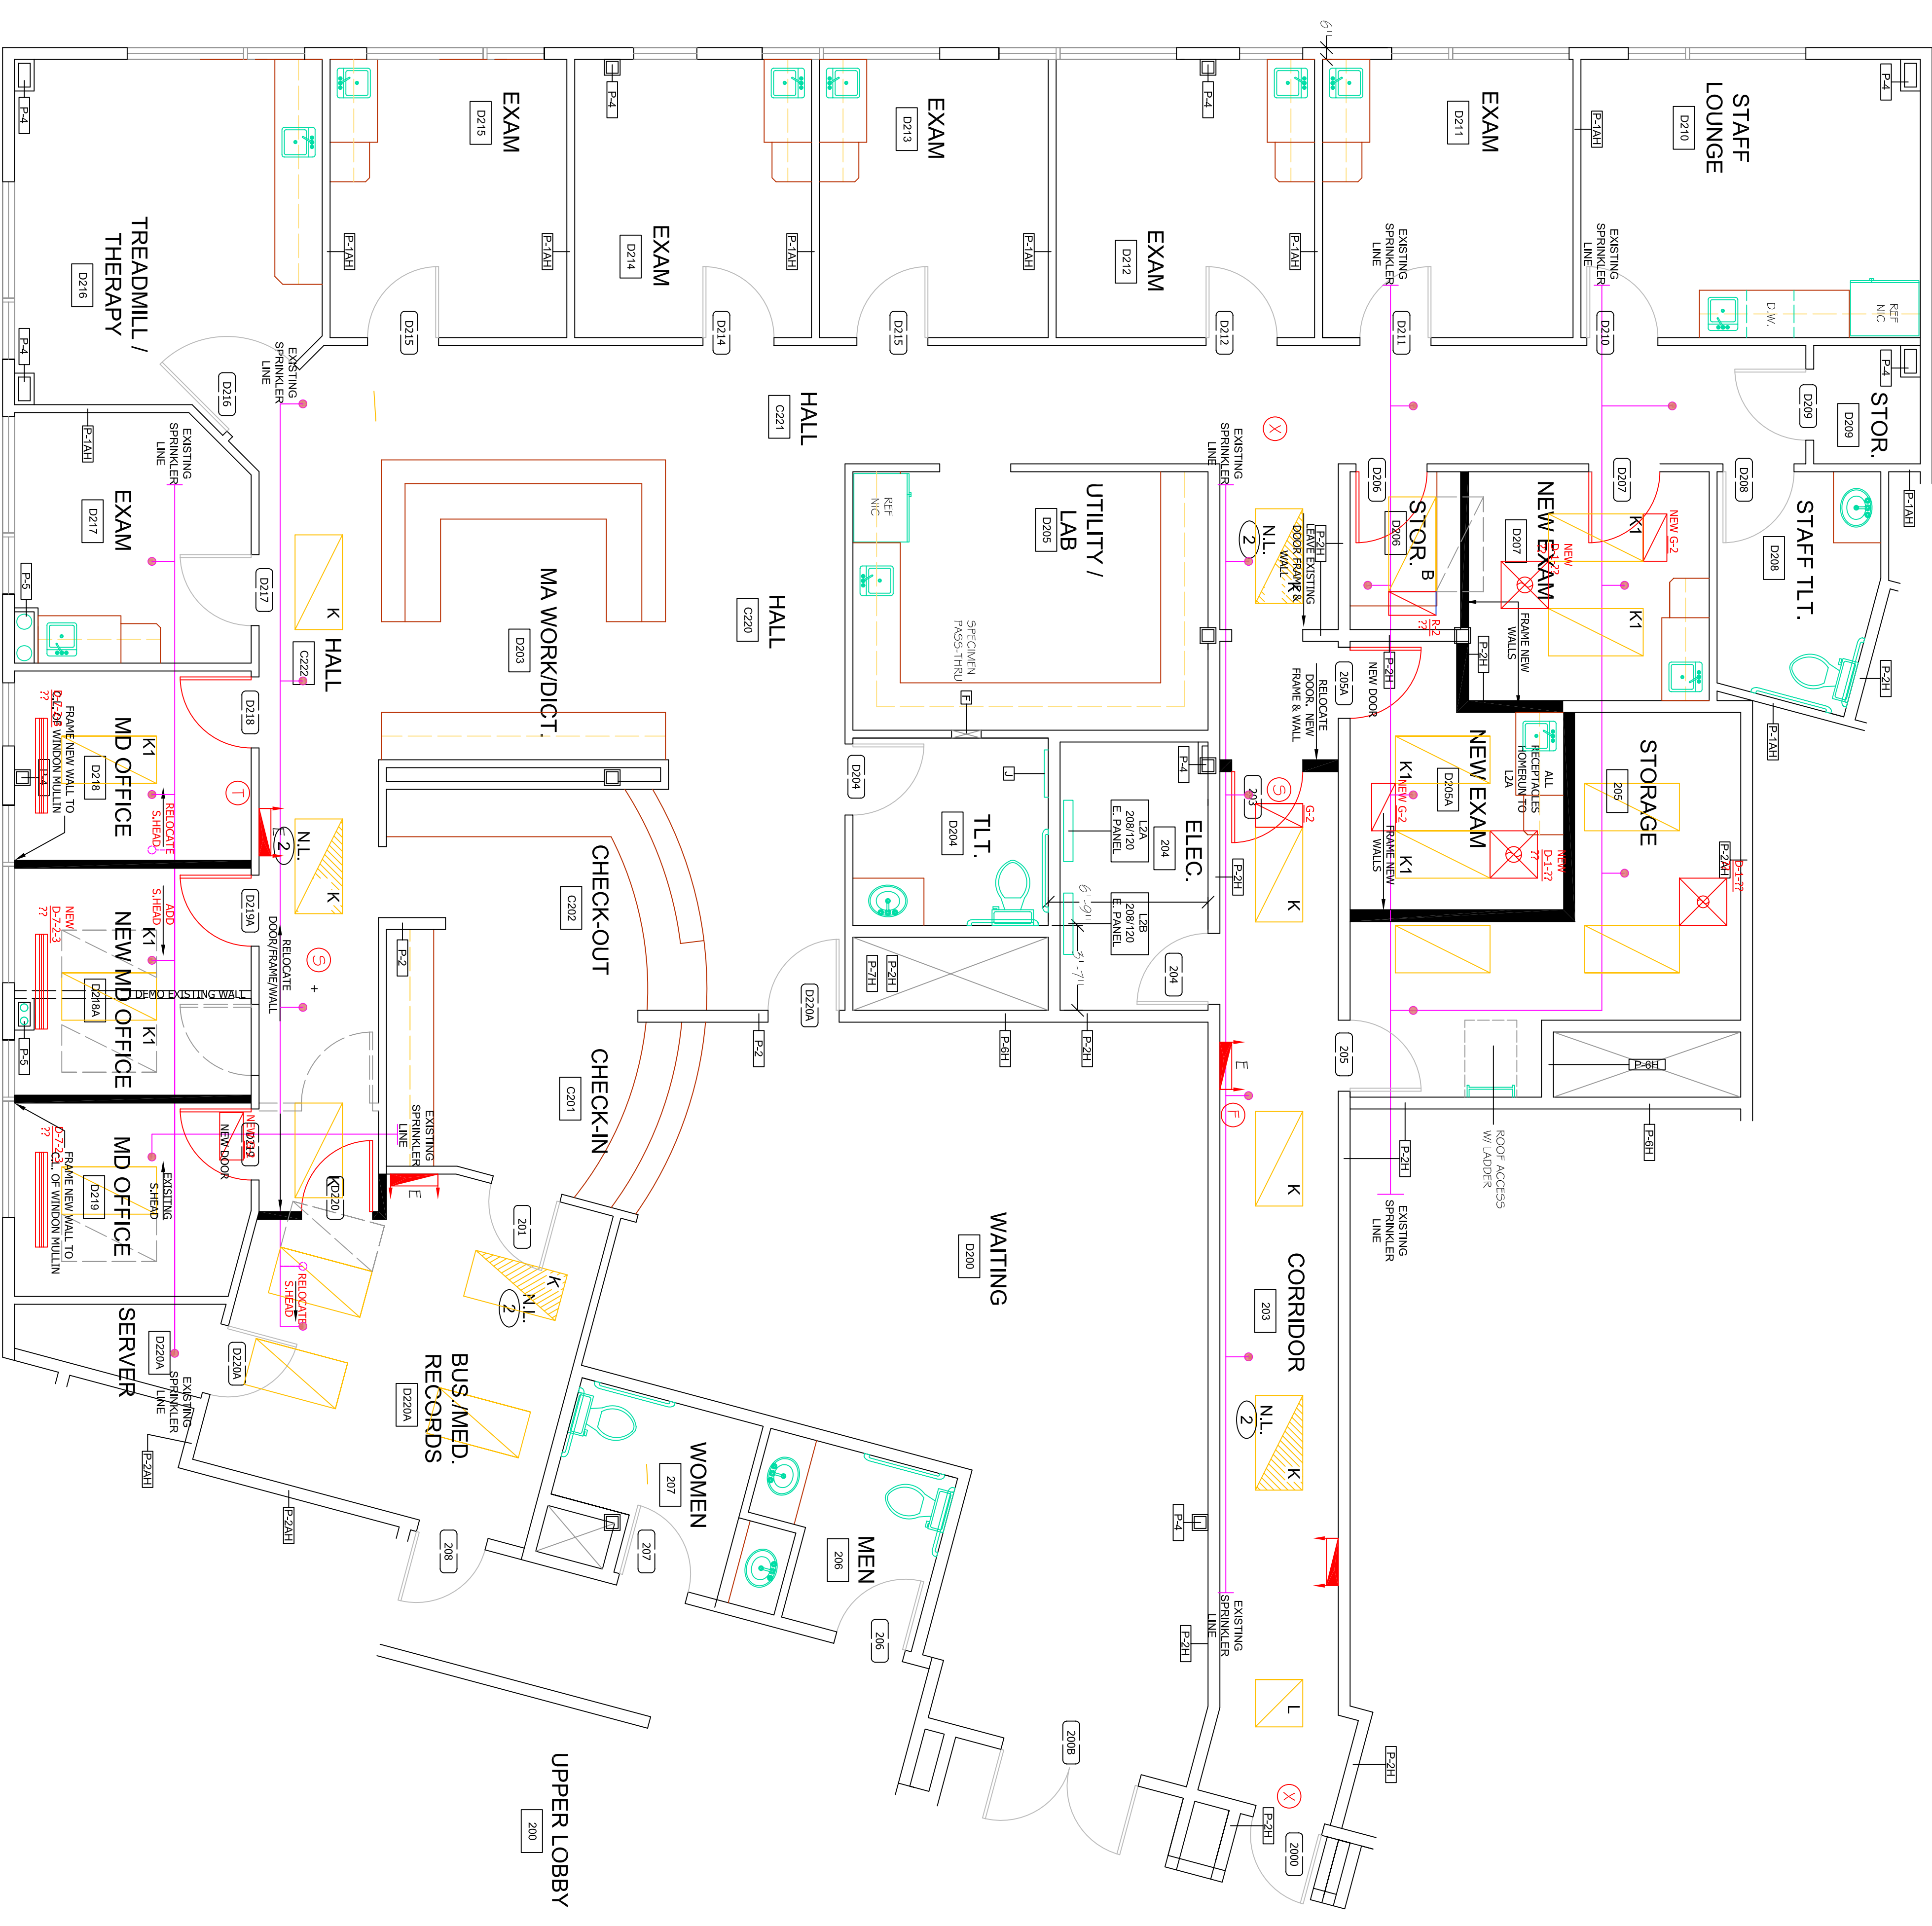

MEDICAL OFFICE CAMPUS SECOND FLOOR REMODEL PROJECT

Date:	4/18/2008	Drawn By:	Sean Carson
Drawn By:	Sean Carson	Design By:	Sean Carson
Form Set:		Drawn By:	Sean Carson

BLUEFEATHER
Design/Build
Associates, LLC

Mailing Address:
P.O. Box 415
Lanark, VA 22073

Phone:
507-760-5998

Email:
scarson@bluefeatherdesignbuild.com

Copyright © 2008, Bluefeather Design/Build Associates
All Rights Reserved
www.BluefeatherDesignBuild.com

FP3-RM1