

I BASEMENT FLOOR ELECTRICAL PLAN


E.300 SCALE: 1/4" = 1'-0"

GENERAL NOTES

1. THE CONTRACTOR AND ALL SUBCONTRACTORS SHALL VERIFY ALL DIMENSIONS AND CONDITIONS AT THE SITE, AND NOTIFY THE OWNER AND BLUEFEATHER DESIGN/BUILD OF ANY DISCREPANCY.
2. ALL WORKMANSHIP AND BUILDING MATERIALS SHALL CONFORM TO THE CURRENT LOCAL AND INTERNATIONAL BUILDING CODES THAT APPLY.
3. ALL PLUMBING, MECHANICAL, AND ELECTRICAL WORK MUST BE DONE BY LICENSED CONTRACTORS.

ELECTRICAL SYMBOL KEY

- 1.5A DUPLEX HOUSE
- 1.5A GFI
- 1.5A GFI WEATHERPROOF
- 20A DUPLEX HOUSE
- 20A GFI
- 20A GFI WEATHERPROOF
- 30A WEATHERPROOF RECEPTACLE
- 50A RANGE
- SP SWITCH
- (2) SP SWITCH
- (3) SWITCH
- 3W SWITCH
- (2) 3W SWITCH
- (3) 3W SWITCH
- SP 3W SWITCH
- SP SP 3W SWITCH
- SP 3W 3W SWITCH
- DIMMER SWITCH, 600W
- 3W DIMMER SWITCH, 600W
- DIMMER SWITCH, 1000W
- 4W SWITCH
- CEILING FIXTURE
-
-
- TV JACK
- TELEDATA JACK
- SMOKE DETECTOR
- BATHROOM FAN
- BATHROOM FANLIGHT
- CEILING FAN
- UNDER CABINET TASK LIGHTING
- FLUORESCENT LIGHT FIXTURE

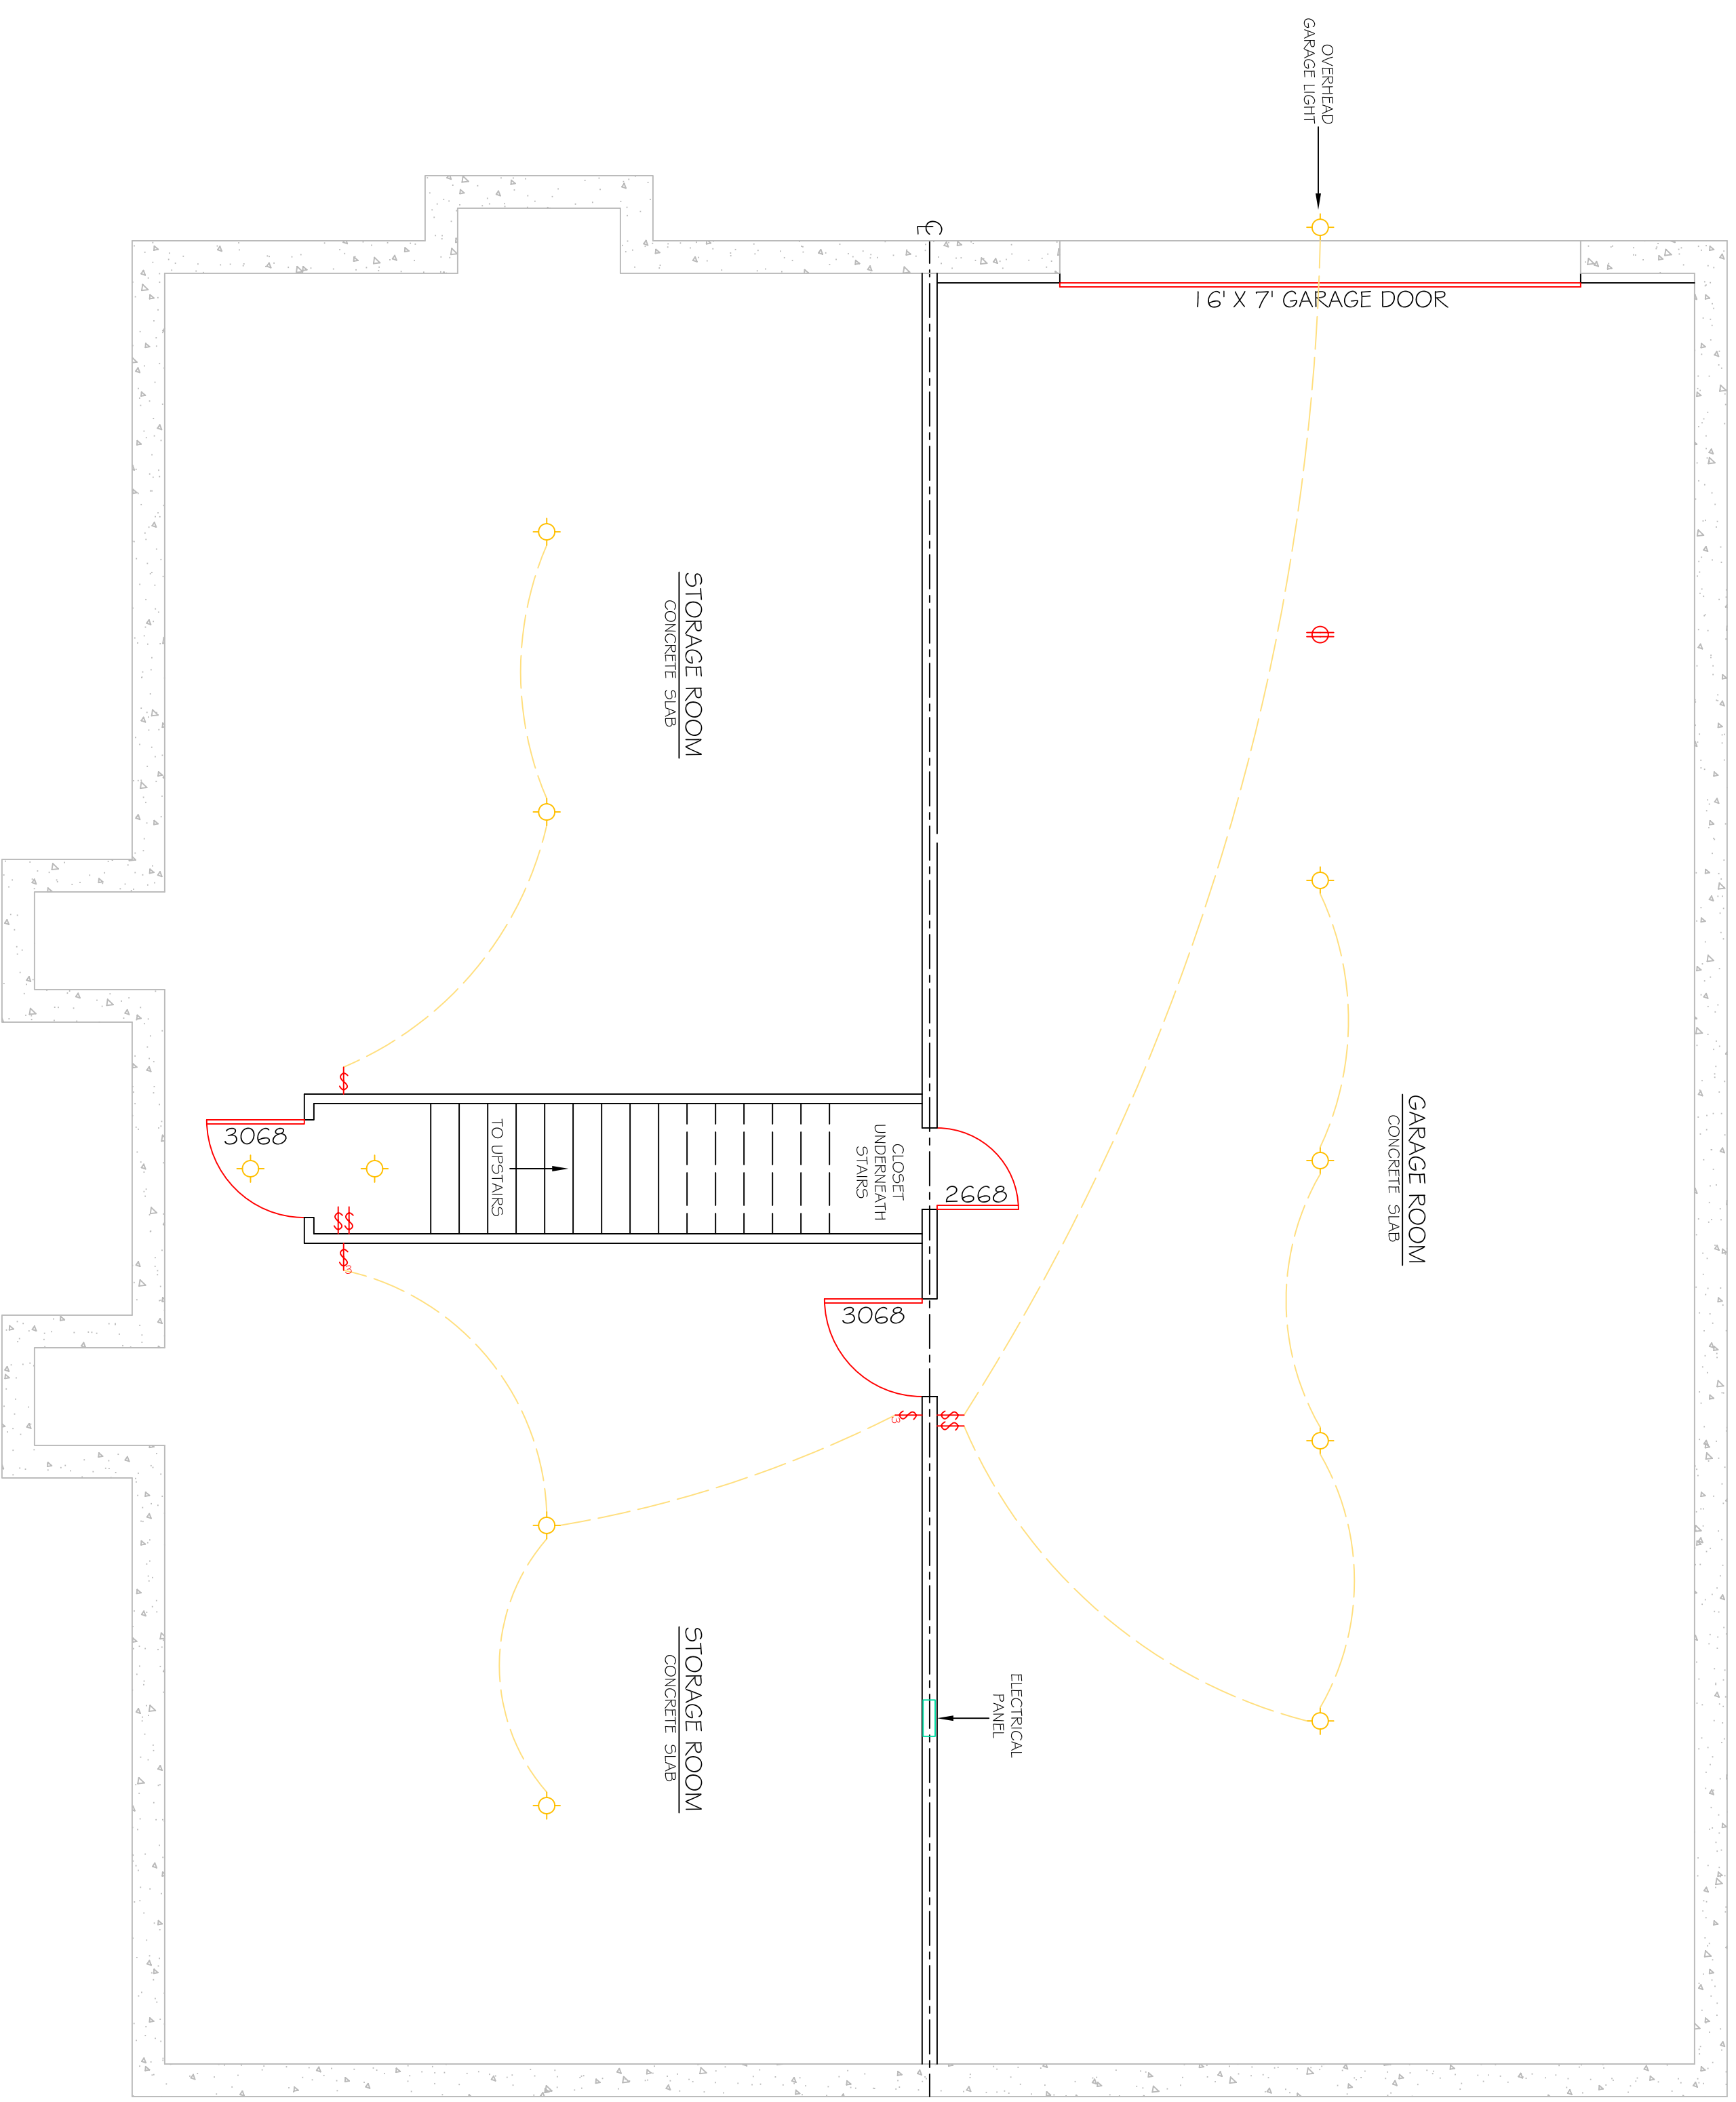

Date:	04/26/2006	Drawn By:	Sean Carson
Date Revised:		Drawn By:	Sean Carson
Final Date:		Drawn By:	Sean Carson
Print Date:		Drawn By:	

Wroblewski Residence
FRANK AND ESTELLE WROBLEWSKI / QUAIL HOLLOW DRIVE / ALLEYTON, TX 78935

BLUEFEATHER
Design/Build
Associates, LLC

John Adams
P.O. Box 415
Laramie, WY 82073
Phone: 307-760-5998
Email: scarson@bluefeatherdesignbuild.com
Copyright 2006
Bluefeather Design/Build Associates
All Rights Reserved
www.bluefeatherdesignbuild.com

E.300